

City of Lafayette
Lafayette Community Center Restroom Renovation
500 St Mary's Rd.
Lafayette, CA 94549
PROJECT NO. 012-9180

ADDENDUM NO. 2

The following clarifications, additions, and deletions shall become a part of the plans and specifications for the above project, and shall be bound by the General Conditions, Technical Specifications, and all other conditions of the Bid Documents.

PROJECT PLANS



1. Sheet A.201 has been revised with changes clouded. Demolition plan (1/A.201) reflects removal of portion of existing concrete slab to accommodate new concrete apron/landing and Floor Plan reflects new concrete apron/landing @ Door 101.

Date: June 14, 2021

CITY OF LAFAYETTE

john warshaw

John Warshaw, Supervisor
Parks, Trails and Recreation Dept.

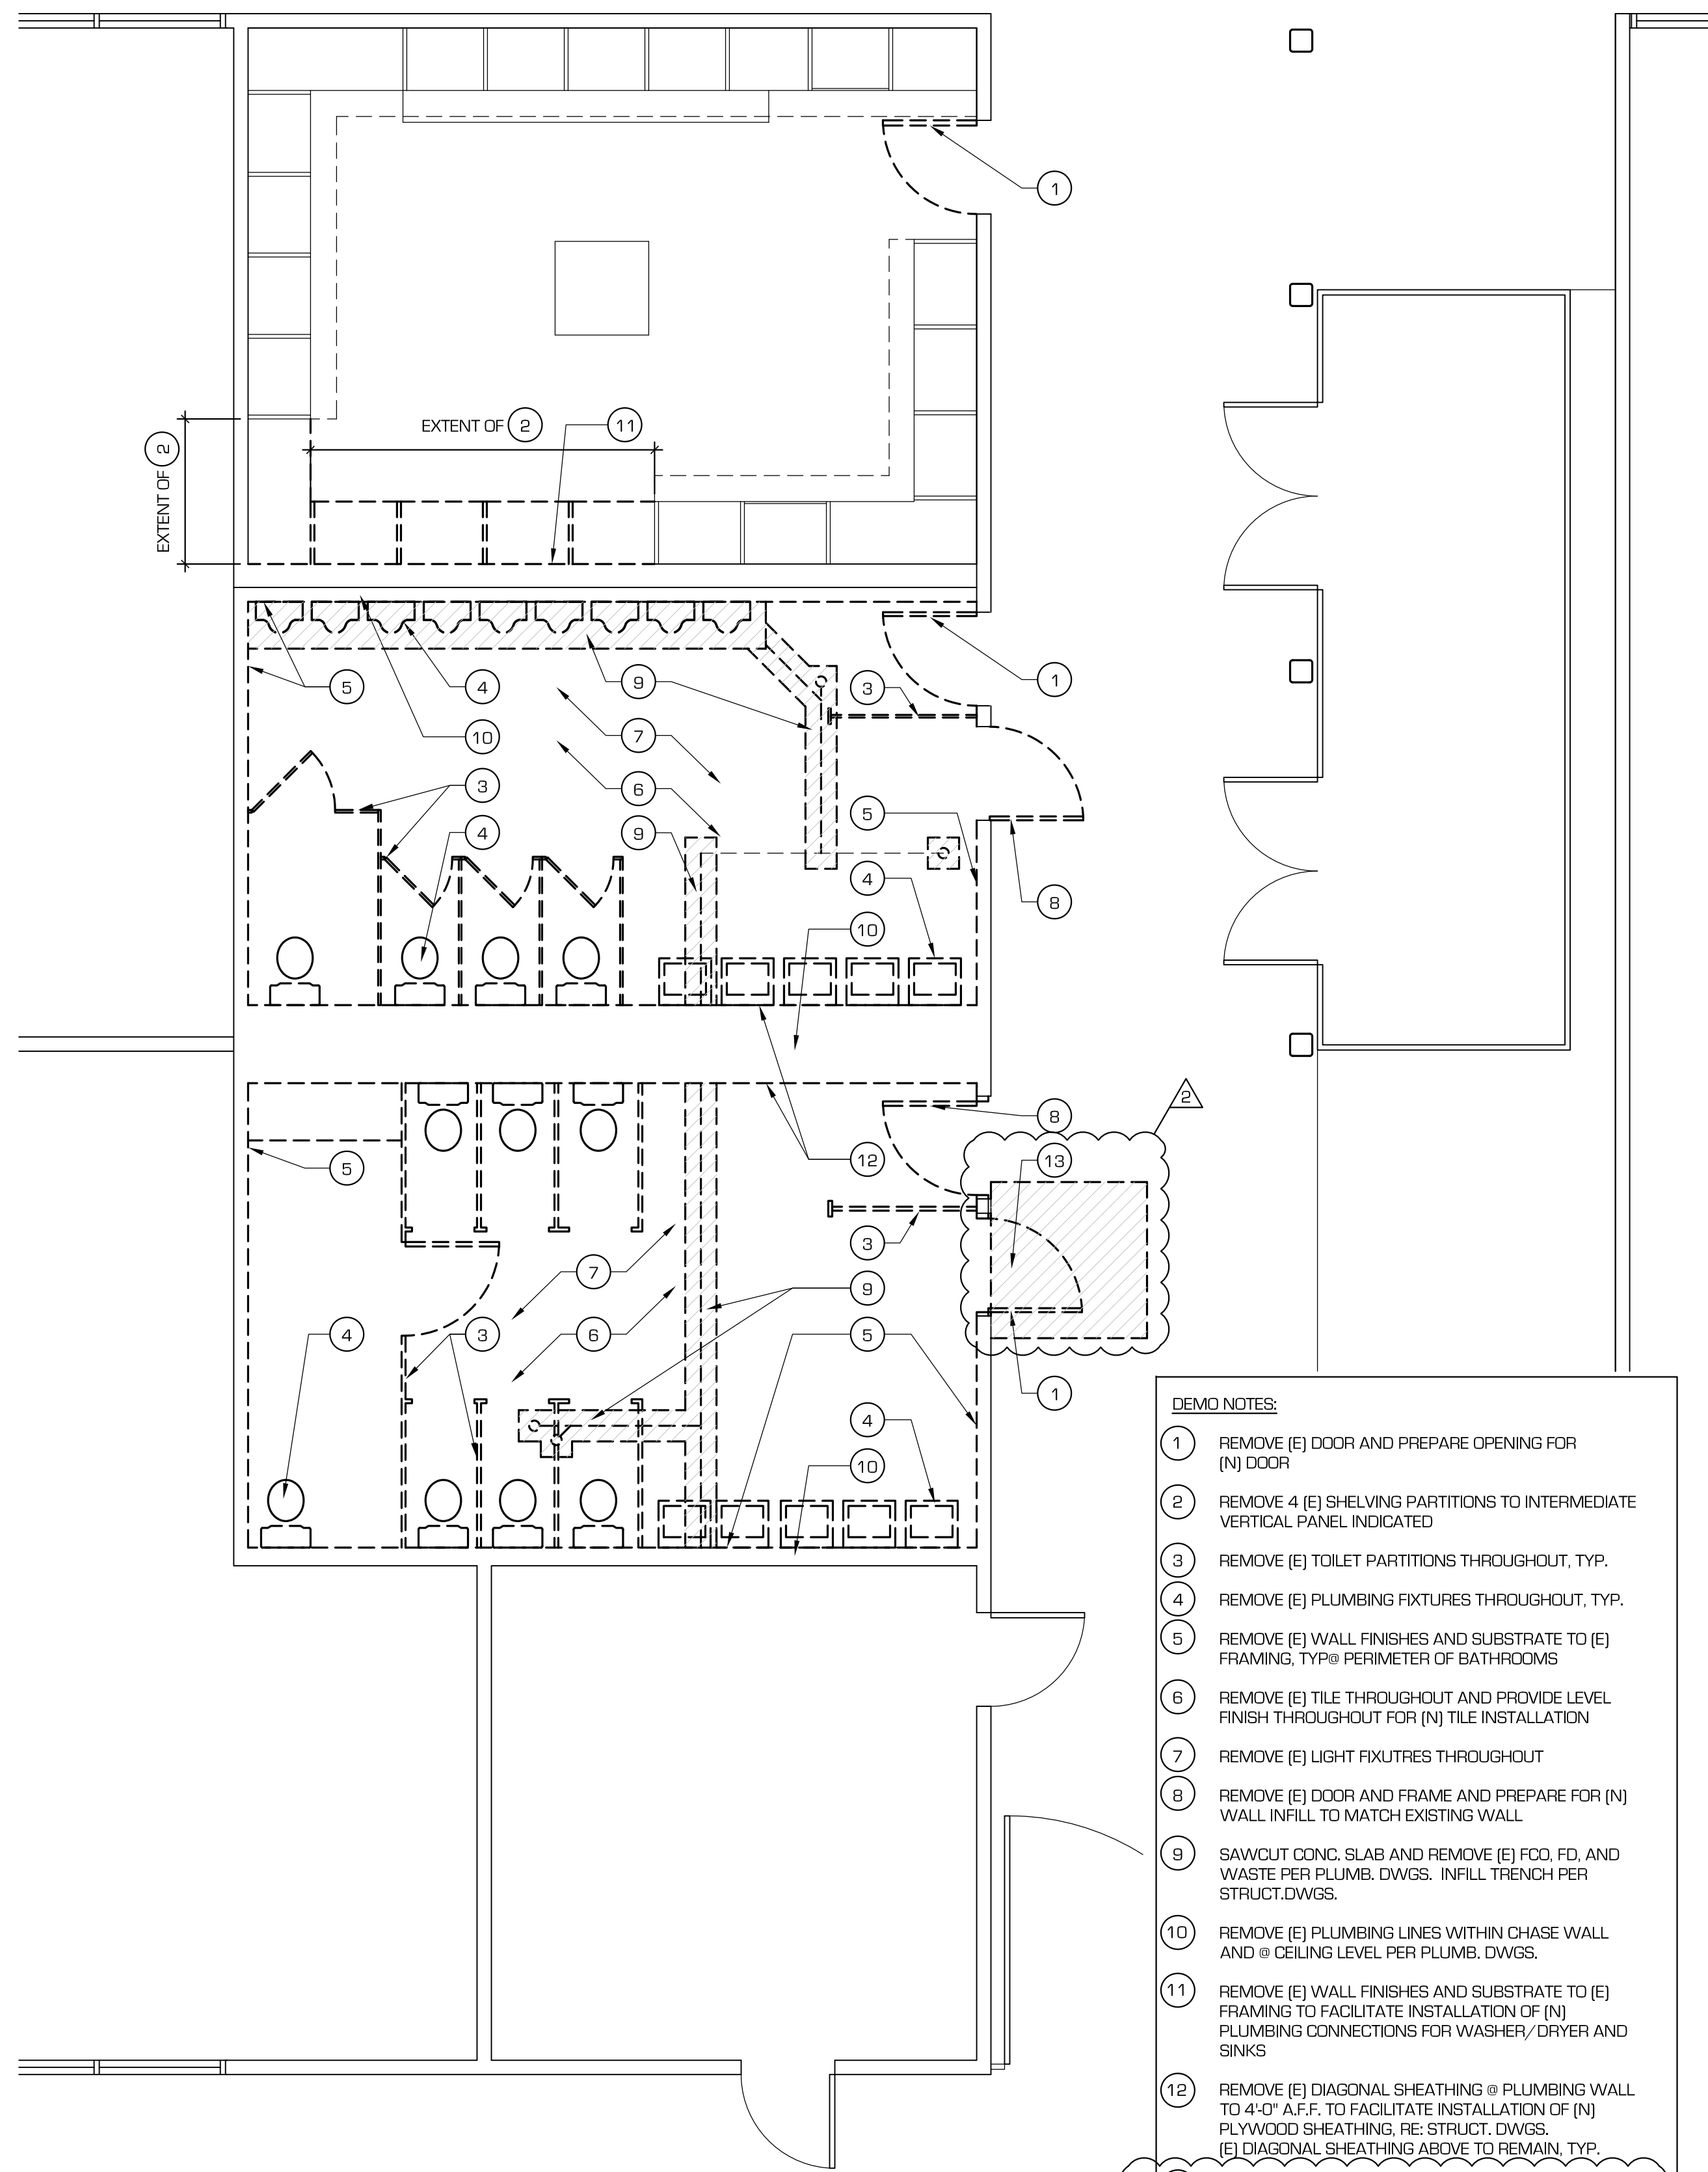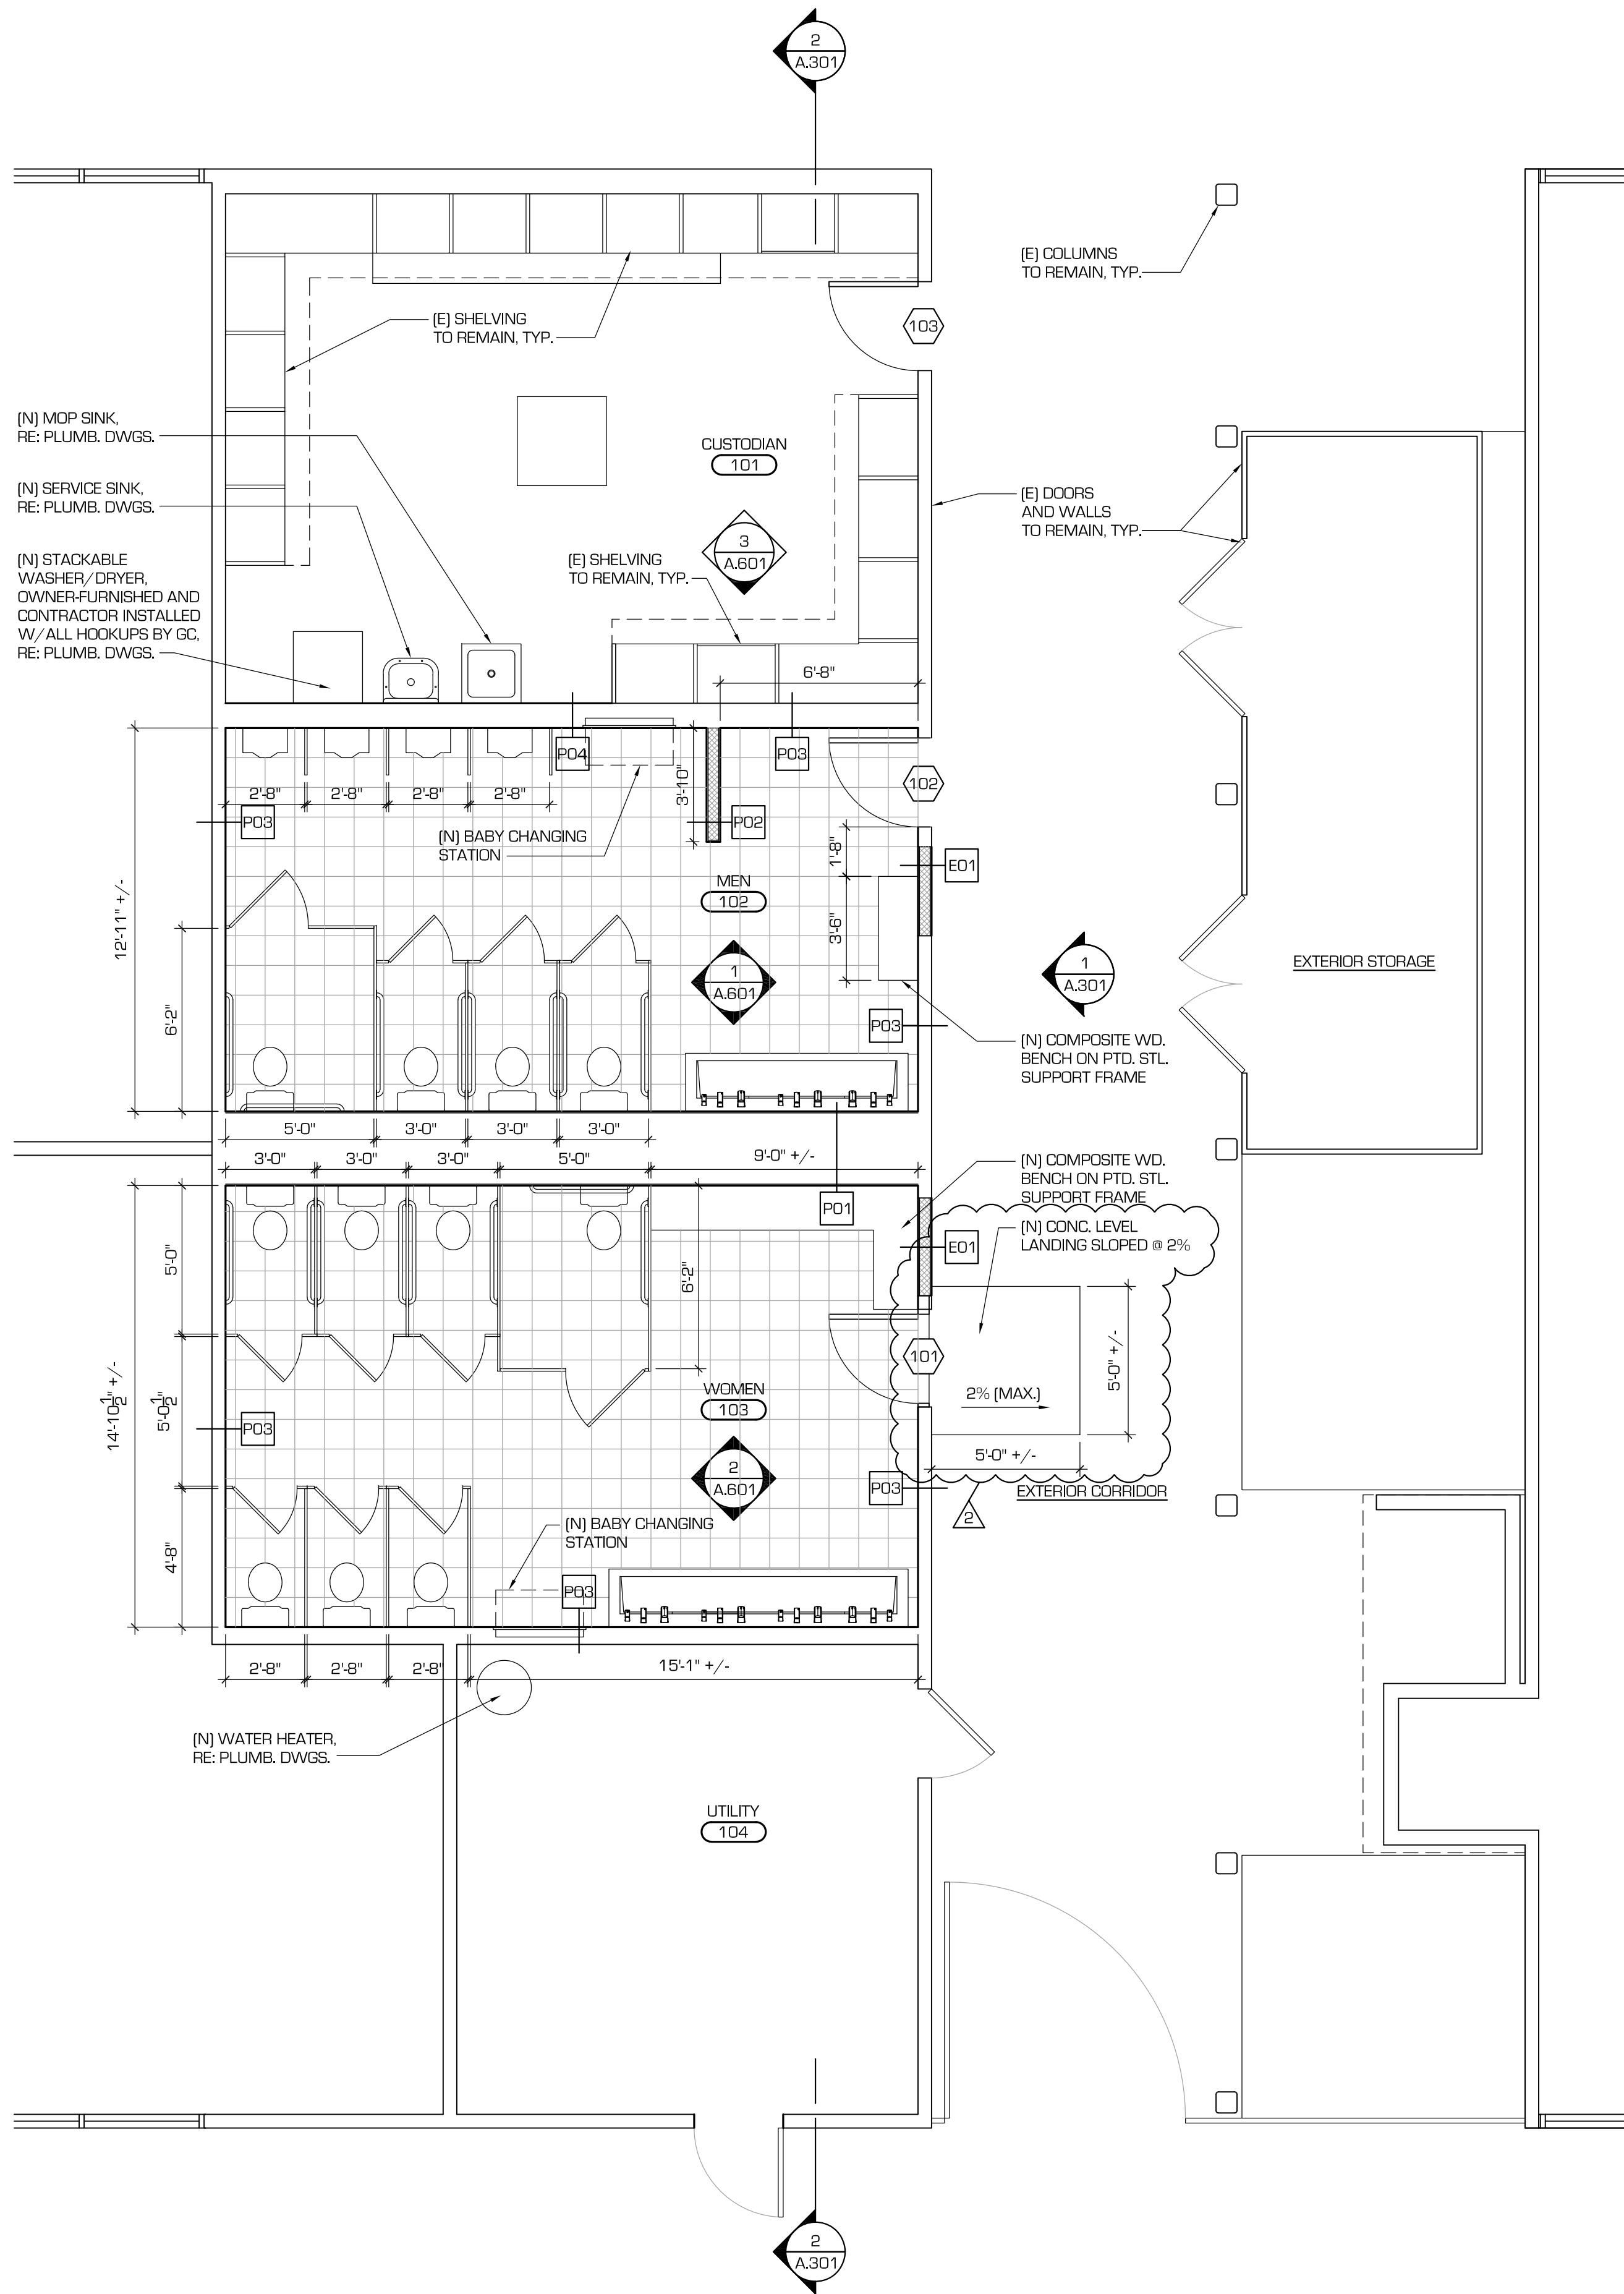

- DEMO NOTES:**
- 1 REMOVE (E) DOOR AND PREPARE OPENING FOR (N) DOOR
 - 2 REMOVE 4 (E) SHELVING PARTITIONS TO INTERMEDIATE VERTICAL PANEL INDICATED
 - 3 REMOVE (E) TOILET PARTITIONS THROUGHOUT, TYP.
 - 4 REMOVE (E) PLUMBING FIXTURES THROUGHOUT, TYP.
 - 5 REMOVE (E) WALL FINISHES AND SUBSTRATE TO (E) FRAMING, TYP@ PERIMETER OF BATHROOMS
 - 6 REMOVE (E) TILE THROUGHOUT AND PROVIDE LEVEL FINISH THROUGHOUT FOR (N) TILE INSTALLATION
 - 7 REMOVE (E) LIGHT FIXTURES THROUGHOUT
 - 8 REMOVE (E) DOOR AND FRAME AND PREPARE FOR (N) WALL INFILL TO MATCH EXISTING WALL
 - 9 SAWCUT CONC. SLAB AND REMOVE (E) FOD, FD, AND WASTE PER PLUMB. DWGS. INFILL TRENCH PER STRUCT.DWGS.
 - 10 REMOVE (E) PLUMBING LINES WITHIN CHASE WALL AND @ CEILING LEVEL PER PLUMB. DWGS.
 - 11 REMOVE (E) WALL FINISHES AND SUBSTRATE TO (E) FRAMING TO FACILITATE INSTALLATION OF (N) PLUMBING CONNECTIONS FOR WASHER/ DRYER AND SINKS
 - 12 REMOVE (E) DIAGONAL SHEATHINGS @ PLUMBING WALL TO 4'-0" A.F.F. TO FACILITATE INSTALLATION OF (N) PLYWOOD SHEATHING, RE: STRUCT. DWGS. (E) DIAGONAL SHEATHING ABOVE TO REMAIN, TYP.
 - 13 REMOVE PORTION OF (E) CONC. SLAB TO ACCOMMODATE (N) CONC. APRON/ LEVEL LANDING. COORDINATE EXTENT OF REMOVAL WITH SLOPES SHOWN ON 2/ A.201. TIE IN (N) CONC. W/ EXISTING PER STRUCT.


2 GROUND FLOOR PLAN
1/4" = 1'-0"

1 DEMOLITION FLOOR PLAN
1/4" = 1'-0"



PROJECT DATA

NO. DATE	ISSUES AND REVISIONS	BY/CHK
11.08.19	DESIGN DEVELOPMENT	BK/AC
10.20.20	PERMIT SET	BK/AC
05.06.21	BID SET	BK/AC
06.14.21	ADDENDUM #2	BK/AC

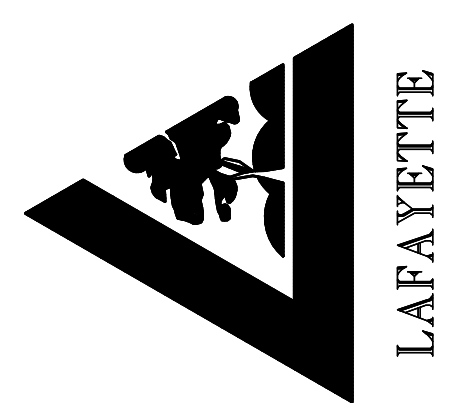

SCALE: 1/4" = 1'-0"
REF NORTH

All drawings and reports are the property of PROTO inc. and shall remain confidential. No part of this document may be reproduced, stored in a retrieval system, or transmitted in any form or by any means, electronic, mechanical, photocopying, recording, or by any information storage and retrieval system, without the prior written consent of the architect.